



Chick-fil-A

Chick-fil-A  
5200 Buffington Road  
Atlanta, Georgia 30349-2998

INTERPLAN

ARCHITECTURE  
ENGINEERING  
INTERIOR DESIGN  
PROJECT MANAGEMENT

604 COURTLAND STREET  
SUITE 100  
ORLANDO, FLORIDA 32804  
PH 407.645.5008  
FX 407.629.9124

SEAL:  
THIS DOCUMENT IS NOT FOR CONSTRUCTION  
UNLESS THE ARCHITECT OR ENGINEER'S  
SIGNATURE AND SEAL APPEAR BELOW

115 Cherokee Place, Cartersville, GA 30121

CHICK-FIL-A  
Cherokee Place FSR

FSR# 00534


REVISION SCHEDULE  
NO. DATE DESCRIPTION  
3 01/12/18 CITY COMMENTS

CONSULTANT PROJECT # 2017.0149  
PRINTED FOR Bid  
DATE November 20, 2017  
DRAWN BY AD

Information contained on this drawing and in all digital files  
produced for above named project may not be reproduced in  
any manner without express written or verbal consent from  
Interplan LLC. RESERVE COPYRIGHT & OTHER RIGHTS RESPECTING THESE DOCUMENTS TO THE ORIGINAL USE OR PURPOSE FOR WHICH THEY WERE PREPARED. REPRODUCTIONS, CHANGES OR ASSIGNMENTS ARE PROHIBITED.

SHEET REFLECTED CEILING PLAN

SHEET NUMBER  
A-221L

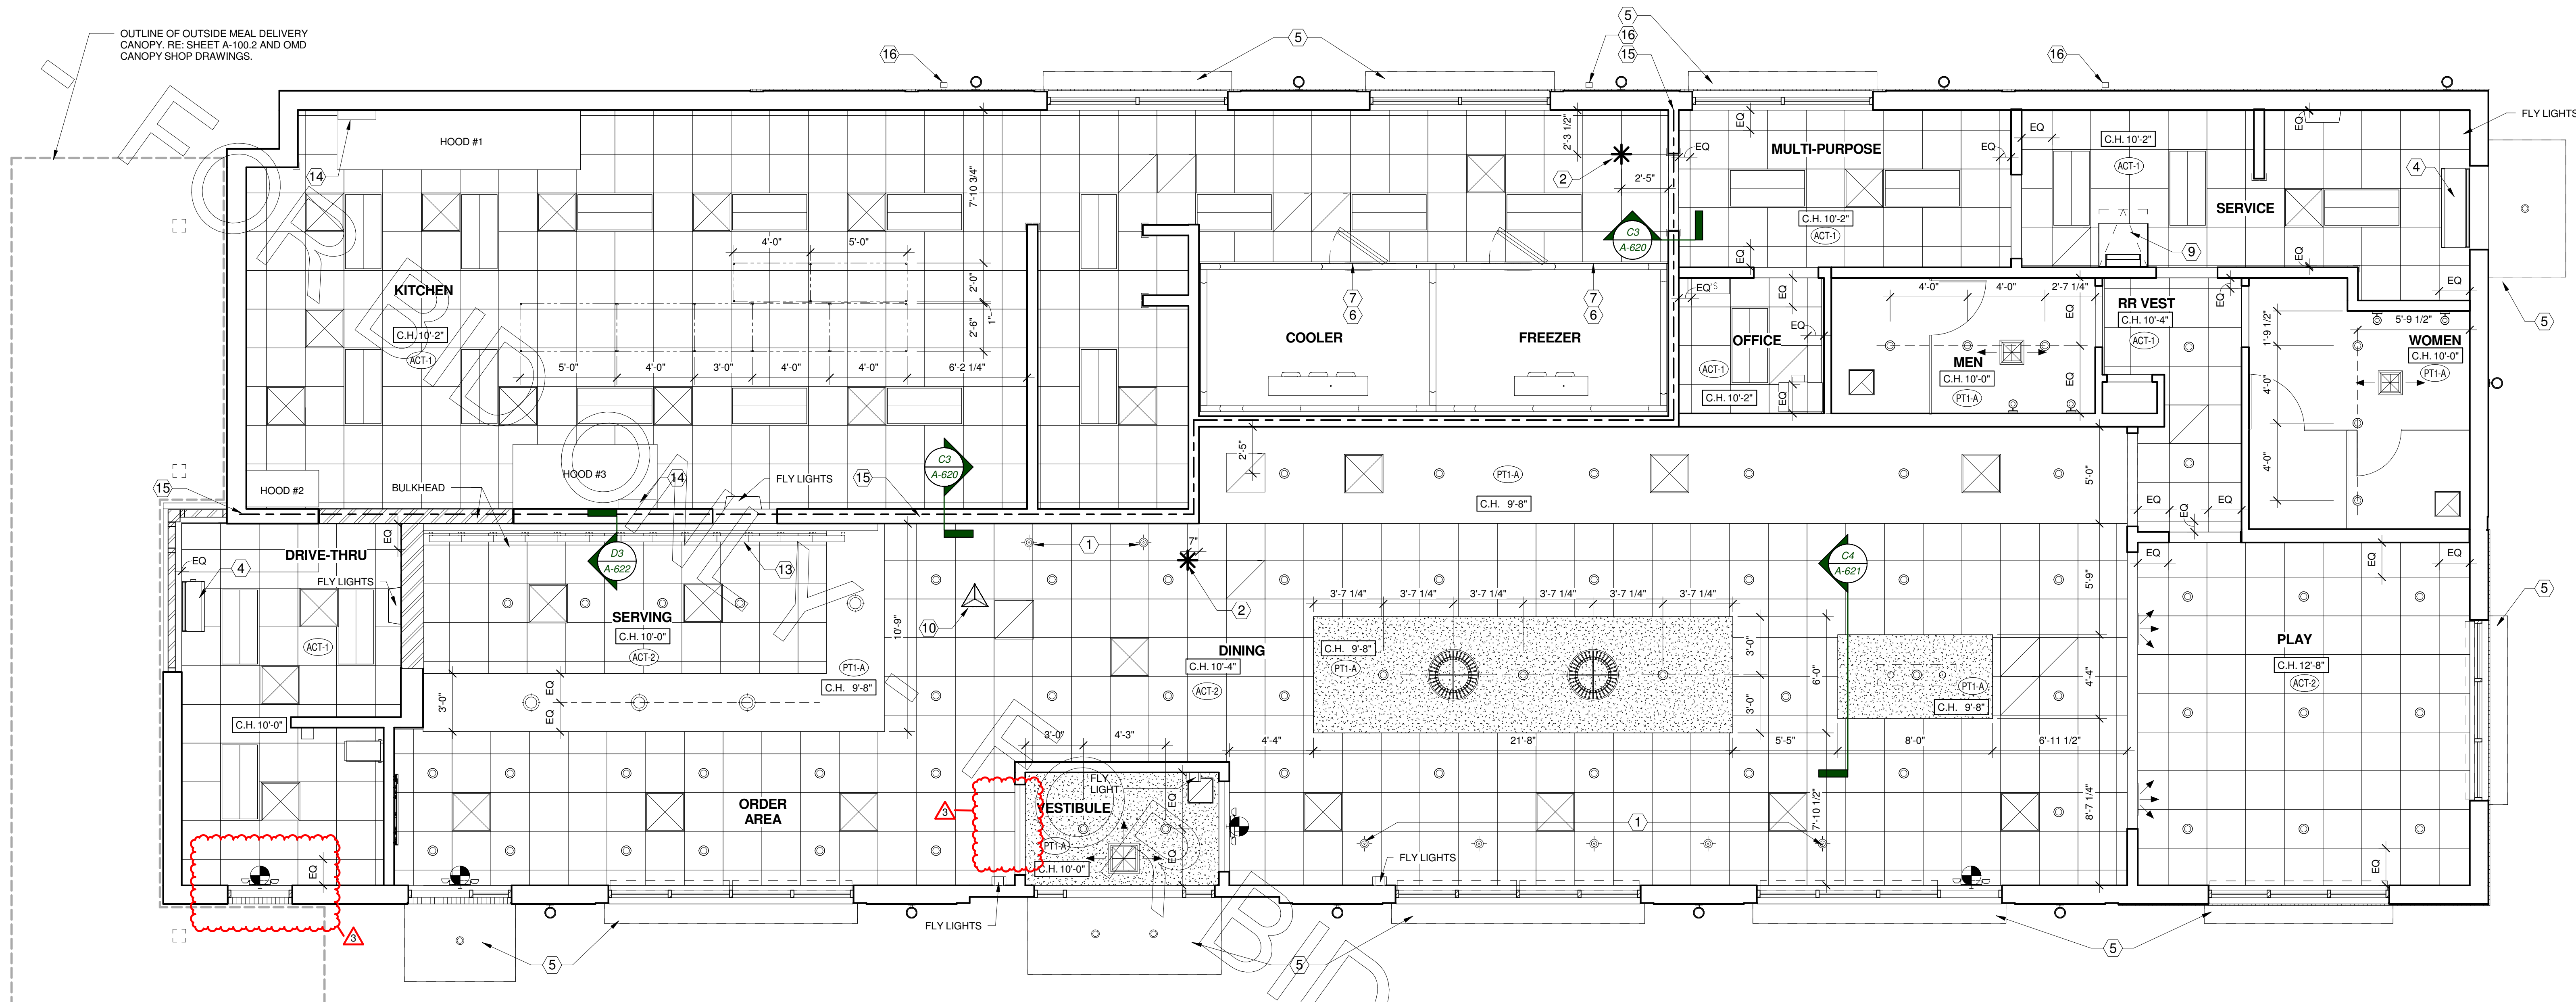

C4 REFLECTED CEILING PLAN - LARGE  
1/4" = 1'-0"

FINISH SCHEDULE - RCP							
R	DESCRIPTION	MANUFACTURER	MODEL NAME	MODEL NUMBER	COLOR	SIZE	NOTE
01	CEILING FINISHES						
ACT-1	ACOUSTICAL CEILING PANEL AND GRID	CERTAINTED	PERFORMA VINYL ROCK	1142-CRF-1	WHITE	24" x 24" x 1/2"	GRID: STANDARD 15/16" SQUARE LAY-IN GRID, WHITE
ACT-2	ACOUSTICAL CEILING PANEL AND GRID	CERTAINTED	PERFORMA SYMPHONY M	1222BF-IOF-1	WHITE	24" X 24" X 3/4"	GRID: ELITE NARROW REVEAL (CORNER BEVEL) 9/16" GRID, WHITE
PT1-A	PRIMARY INTERIOR CEILING PAINT	SHERWIN WILLIAMS	PRO MAR 200 ZERO VOC PAINT	SW-7011	NATURAL CHOICE		FINISH: FLAT (SEMI-GLOSS ON HARDIE PANEL)
PT3-A	INTERIOR CEILING PAINT	SHERWIN WILLIAMS	PRO MAR 200 ZERO VOC PAINT	SW-7600	BOLERO		FINISH: FLAT
PT5-A	INTERIOR CEILING PAINT	SHERWIN WILLIAMS	PRO MAR 200 ZERO VOC PAINT	SW-7031	MEGA GRIEGE		FINISH: FLAT

#### REFLECTED CEILING PLAN GENERAL NOTES

- A.1 REFER TO FINISHES FOR FINISH INFORMATION NOT SHOWN ON THIS SHEET.  
A.2 REFER TO MECHANICAL AND ELECTRICAL FOR INFORMATION ON LIGHT FIXTURES AND MECHANICAL FIXTURES.  
A.3 ADJUST EXACT LOCATION OF LIGHT FIXTURES TO CLEAR CEILING GRID AND HVAC GRILLES.  
A.4 IN GYPSUM BOARD CEILINGS, ALIGN FIXTURES AND GRILLES BETWEEN CEILING JOISTS.  
A.5 DIMENSIONS SHOWN ARE TO FACE OF FINISH.  
A.6 CEILING SPEAKERS ARE NOT SHOWN HERE. SPEAKERS SHALL BE PROVIDED AND INSTALLED BY OWNER'S SUPPLIER. WHERE SPEAKERS OCCUR IN LAY-IN CEILING, SPEAKERS SHALL BE CENTERED WITHIN CEILING TILES. GC SHALL COORDINATE WITH OWNER'S SPEAKER SUPPLIER AND CUT HOLES IN CEILING AS REQUIRED FOR SPEAKER PLACEMENT.  
A.7 HEIGHTS SHOWN AT CEILINGS ARE TO BOTTOM OF FINISH.  
A.8 HEIGHTS SHOWN AT LIGHT FIXTURES ARE TO BOTTOM OF FIXTURE.

#### REFLECTED CEILING PLAN KEYNOTES - LRG

- 1 ALIGN PENDANTS OVER CENTER OF TABLES BELOW.  
2 CEILING GRID START POINT  
4 AIR CURTAIN - RE: MECHANICAL  
5 PREFINISHED METAL CANOPY BY CANOPY FABRICATOR.  
6 FRP CORNER GUARDS & TRIM AT COOLER AND FREEZER SOFFITS.  
7 METAL CLOSURE PANELS ABOVE FREEZER AND COOLER. INSTALL AFTER CEILING GRID IS IN PLACE. RE: KITCHEN EQUIPMENT DRAWINGS.  
9 ROOF HATCH  
10 3-SIDED PICK-UP SIGN MOUNTED TO CEILING GRID. PROVIDED BY OWNER.  
13 MENU BOARDS  
14 ANSUL CABINET  
15 HEAVY LINE INDICATES SMOKE PARTITION REQUIRED FOR NON-SPRINKLERED BUILDINGS. EXTEND WALL FRAMING FROM FINISH CEILING TO ROOF DECK TO FORM CONTINUOUS SMOKE PARTITION SEPARATING CEILING PLENUM INTO TWO DISTINCT VOLUMES. AT "BACK OF HOUSE" OR KITCHEN SIDE OF WALL, EXTEND SHEATHING FROM FLOOR TO ROOF DECK. ON DINING SIDE, EXTEND WALL SHEATHING FROM FLOOR TO 6" ABOVE FINISH CEILING. RE: DRAFTSTOPPING DETAIL.  
16 DOWNSPOUT.

#### LEGEND:

- LAY-IN CEILING TILE  
CEILING GRID  
START POINT  
GYPSUM BOARD  
RE: FINISH PLAN FOR FINISHES  
EXTERIOR CANOPY  
2' X 4' RECESSED LED  
LIGHT FIXTURE (B.O.H.)  
RECESSED CAN LIGHT FIXTURE  
EXIT LIGHT - WALL MOUNTED  
EXTERIOR LIGHT FIXTURE  
SEE EXTERIOR ELEVATIONS FOR WALL  
MOUNTED LIGHT LOCATIONS U.N.O.  
ELECTRICAL DROP CORDS  
RE: ELECTRIC  
PENDANT LIGHT  
DOME LIGHT FIXTURE  
SPEAKER  
PEACH BASKET PENDANT  
COCA-COLA LIGHT FIXTURE  
FLY LIGHT - RE: KITCHEN  
FLY LIGHT - RE: ELECTRICAL  
AIR CURTAIN - RE: MECH.